

GRATING PLAN (THICKNESS IN MM. SHOWN).  
EDGE PROFILES, REF. DWG. W2HT/BN286

CONCRETE SLABS:

AREA	THICKNESS	REINFORCEMENT	POSITION FROM TOP
SLABS ON FILL	200	φ 16/150 BD	80 MM

SYMBOLS:

- FIXED EARTH TERMINAL REF. DWG. W2UZB/EE120. HORIZONTAL POSITION.
- FIXED EARTH TERMINAL REF. DWG. W2UZB/EE120. VERTICAL POSITION IN LEVEL 161.800 UNLESS OTHERWISE SHOWN.

NOTES:

- MEASURES IN MM. LEVELS IN M.
- GENERAL NOTES REFER DWG. W2HT/BA101.
- EARTHING AND LIGHTNING REF. DWG. W2UZB/LE110.
- CAST-IN φ200 FLEXIBLE TUBES FOR CABLES. MIN. BENDING RADIUS 600 MM. C TUBE LEVEL 160.700.
- DETAILS AS FOR ABSORBER BUILDING C, UNLESS OTHERWISE SPECIFIED.
- JOINT TYPES (a, b, c, d, e) REF. DWG. W2HT/BN290.
- JOINT TYPES d AND e AT TRENCH SIDES ALSO.
- 30 MM GRATING, EDGE PROFILES REF. DWG. W2HT/BN286.
- TO BE CONFIRMED BY ELEVATOR SUPPLIER.
- STAIRS, REF. DWG. W2UVX/BR137.
- RECESSES AND STARTER BARS FOR LANDINGS REF. DWG. W2UVX/BN203.

RELEASED FOR CONSTRUCTION

RÅDGIVENDE INGENIØRER **ISC** CONSULTING ENGINEERS

Rev. #	EA	230896	MFO	230896	PW	230896	AS SHOWN
Rev. #	ED	220396	PW	220396	PW	220396	EARTH TERMINALS ADDED + AS SHOWN
Rev. #	ED	080396	MFO	080396	PW	080396	AS SHOWN
Original	ED	150995	LBP	150995	PW	150995	Revision in zone / Description.
Sign	Date	Sign	Date	Sign	Date	Welding symbols	Scale: 1:125
Designed:	Checked:	Approved:	Adhere to general instruction		Original format: A1		

External identity  
**PRZEDSIĘBIORSTWO PAŃSTWOWE ELEKTROWNIA IM. T. KOŚCIUSZKI**

Title:  
**Polaniec Power Station**  
Flue gas desulphurisation plant  
FGD-plant (C-D). Abs. & Central Bld.  
Floor Plan, Level 161.300, System  
Concrete structures



Projection convent.:  
**ISO-E:** Ver. 2

Status: / of /  
Page: / of /  
CAD file: A01393AG.DWG  
Drawing No.: W2HT/BR120q

**FLS mija** FLS mija s/a Copenhagen Denmark



830

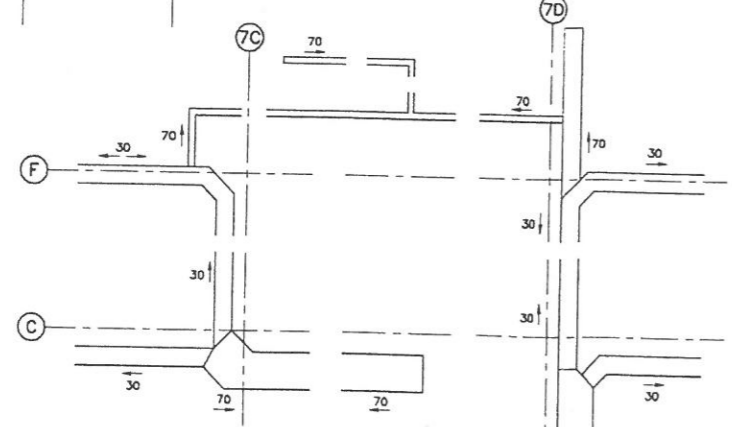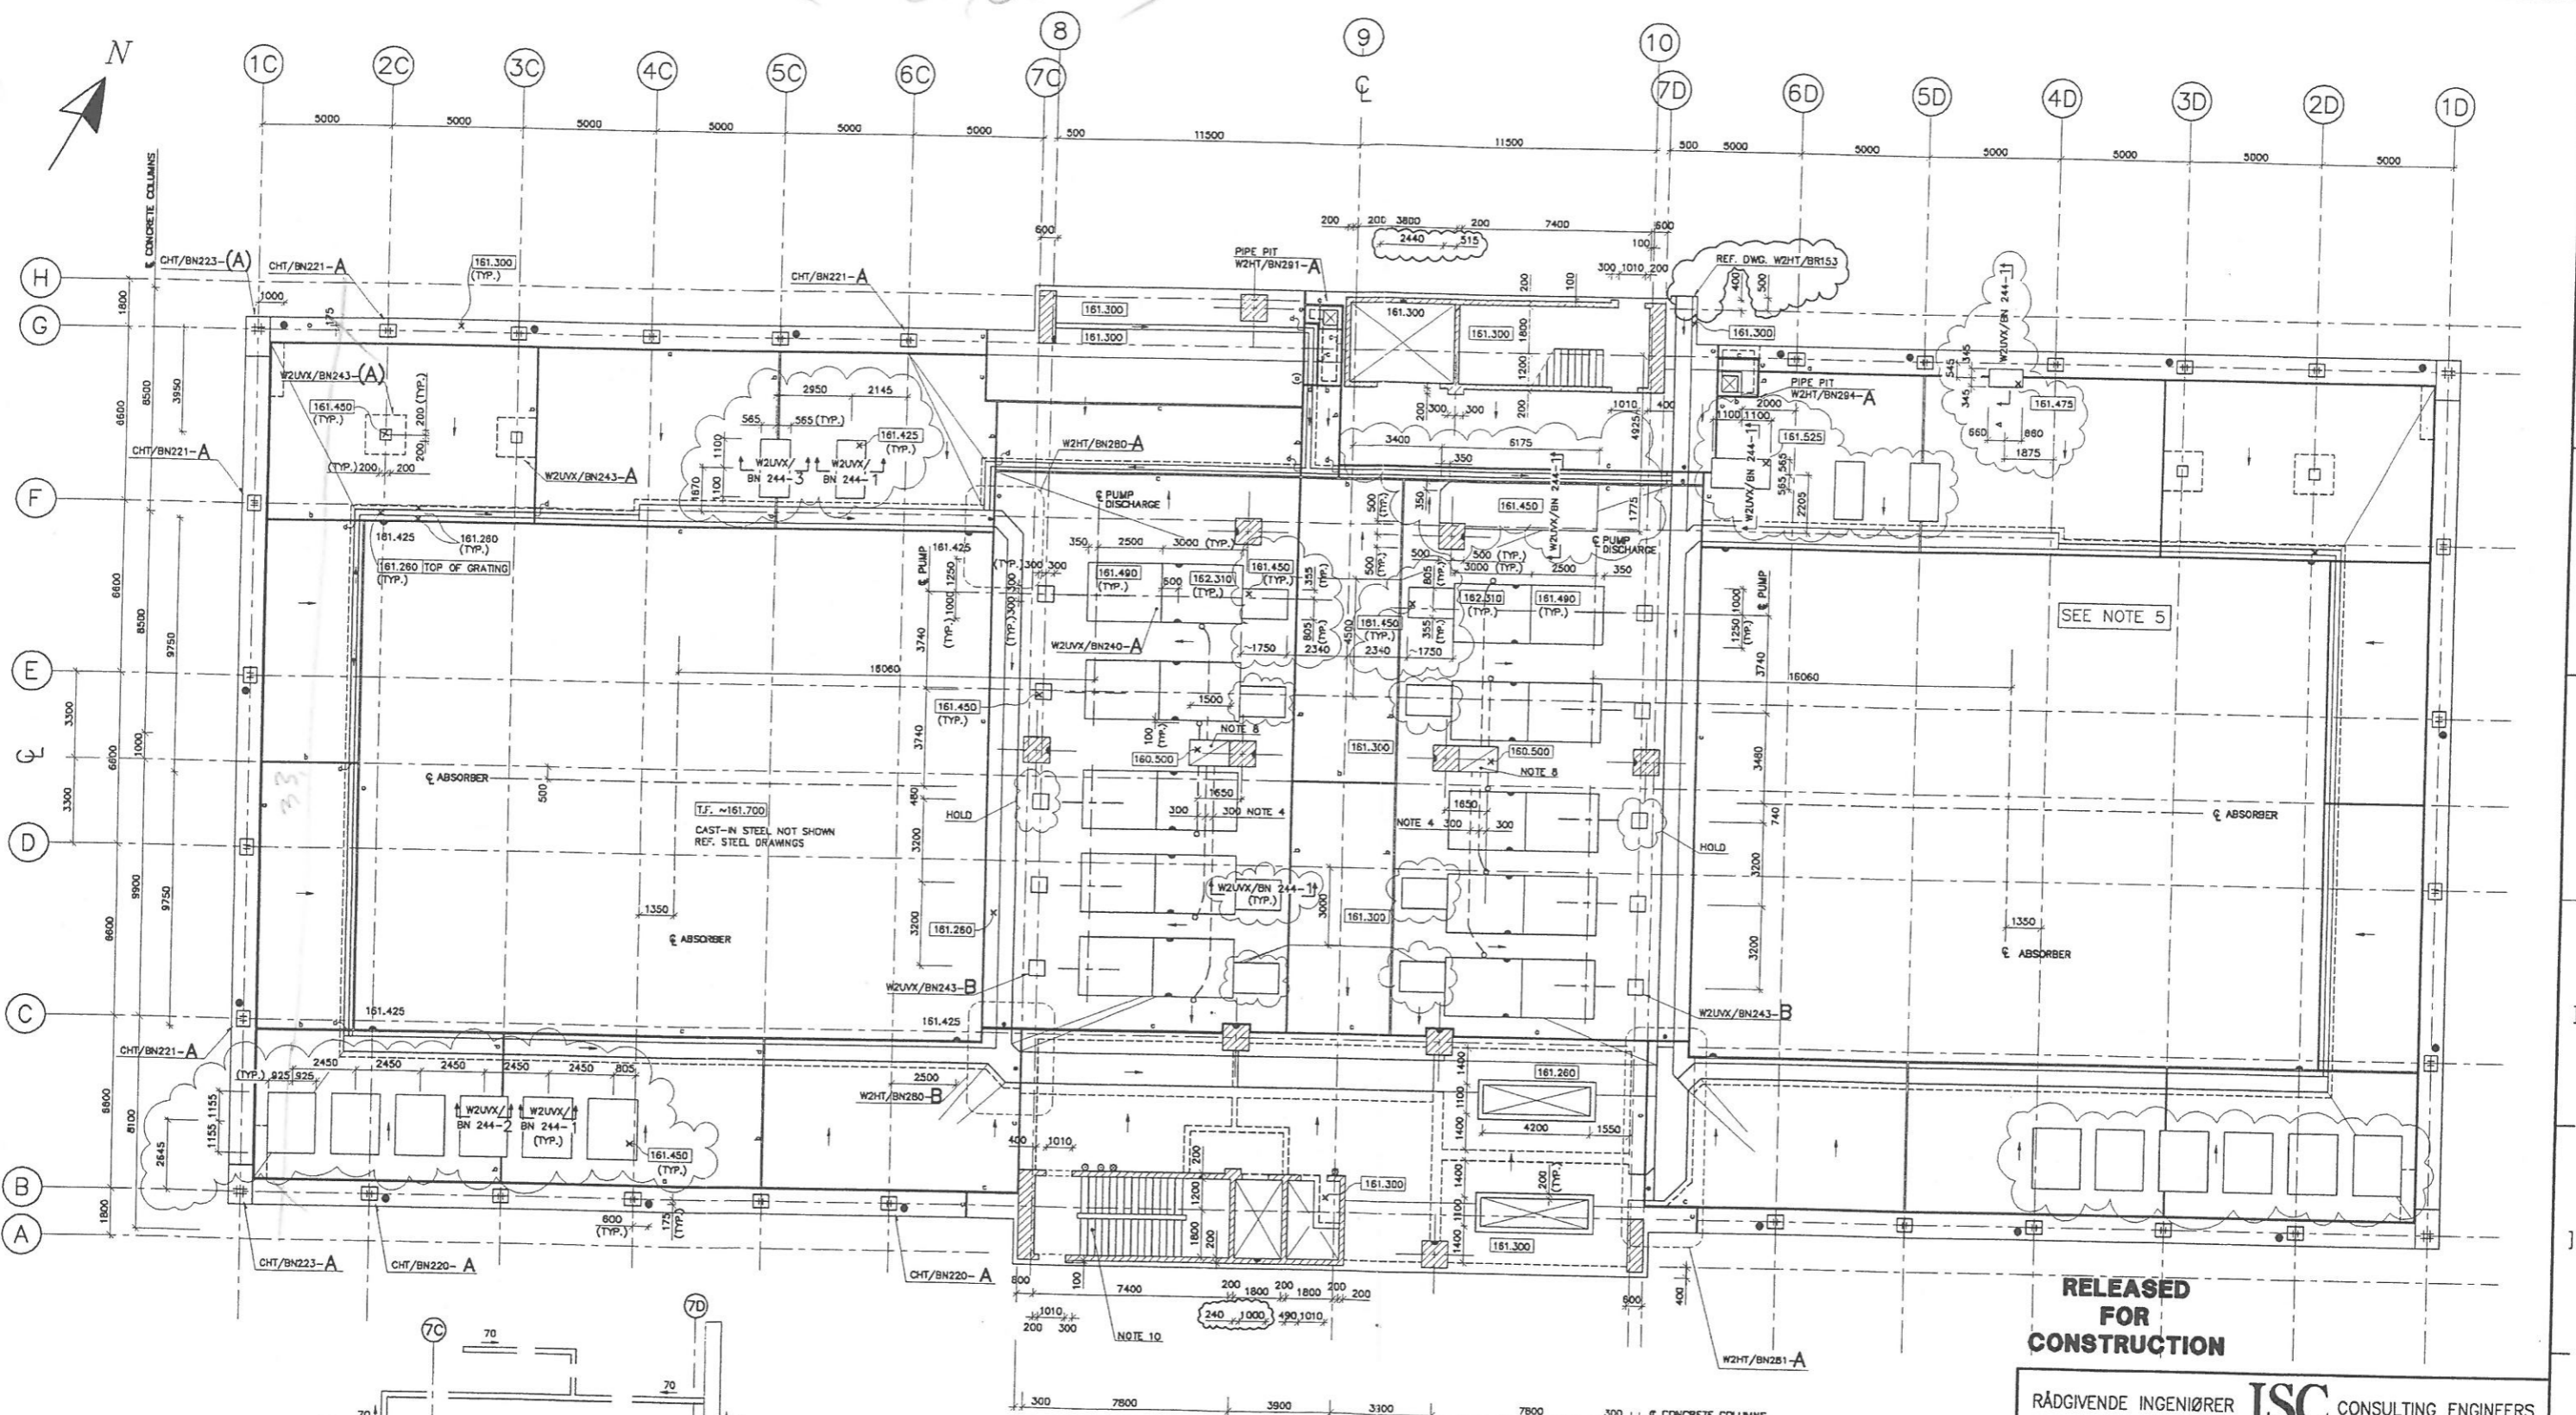

GRATING PLAN (THICKNESS IN MM. SHOWN)  
EDGE PROFILES, REF. DWG. W2HT/BN286

**CONCRETE SLABS:**

AREA	THICKNESS	REINFORCEMENT	POSITION FROM TOP
SLABS ON FILL	200	Ø 16/150 BD	80 MM

**SYMBOLS:**

- FIXED EARTH TERMINAL REF. DWG. W2UZB/EE120. HORIZONTAL POSITION.
- ⦿ FIXED EARTH TERMINAL REF. DWG. W2UZB/EE120. VERTICAL POSITION IN LEVEL 161.800 UNLESS OTHERWISE SHOWN.

**NOTES:**

- MEASURES IN MM. LEVELS IN M.
- GENERAL NOTES REFER DWG. W2HT/BA101.
- EARTHING AND LIGHTNING REF. DWG. W2UZB/LE110.
- CAST-IN Ø200 FLEXIBLE TUBES FOR CABLES, MIN. BENDING RADIUS 600 MM. Ç TUBE LEVEL 160.700.
- DETAILS AS FOR ABS. BUILDING C, UNLESS OTHERWISE SPECIFIED.
- JOINT TYPES (a, b, c, d, e) REF. DWG. W2HT/BN290.
- JOINT TYPES d AND e AT TRENCH SIDES ALSO.
- 30 MM GRATING, EDGE PROFILES REF. DWG. W2HT/BN286.
- STAIRS, REF. DWG. W2UXV/BR137.
- RECESSES AND STARTER BARS FOR LANDINGS REF. DWG. W2UXV/BN203.

**RÅDGIVENDE INGENIØRER ISC CONSULTING ENGINEERS**

Rev. h	MFO 020597	EGP 020597	PVJ 020597	EQUIPMENT FOUND. ADDED.
Rev. g	EGP 230896	MFO 230896	PVJ 230896	AS SHOWN
Rev. f	EGP 220396	PVJ 220396	PVJ 220396	EARTH TERMINALS ADDED + AS SHOWN
Original	EGP 150995	UBP 150995	PVJ 150995	Revision in zone: / Description:

Sign. Date Sign. Date Sign. Date Welding symbols: ISO-E Scale: 1:125  
 Adhere to general instruction: Original format: A1

External identity:  
**PRZEDSIĘBIORSTWO PAŃSTWOWE ELEKTROWNIA IM. T. KOŚCIUSZKI**

Title:  
**Polaniec Power Station**  
 Flue gas desulfurisation plant  
 FGD-plant (C-D). Abs. & Central Bl.  
 Floor Plan, Level 161.300, System  
 Concrete structures

Projection convent.: ISO-E Status: Ver. 2  
 Page: / of /  
 CAD file: A01393AH.DWG  
 Drawing No.: W2HT/BR120h

FLS miljø FLS miljø a/s Copenhagen Denmark